



**FIGURE 12-1
WATER BALANCE DIAGRAM**

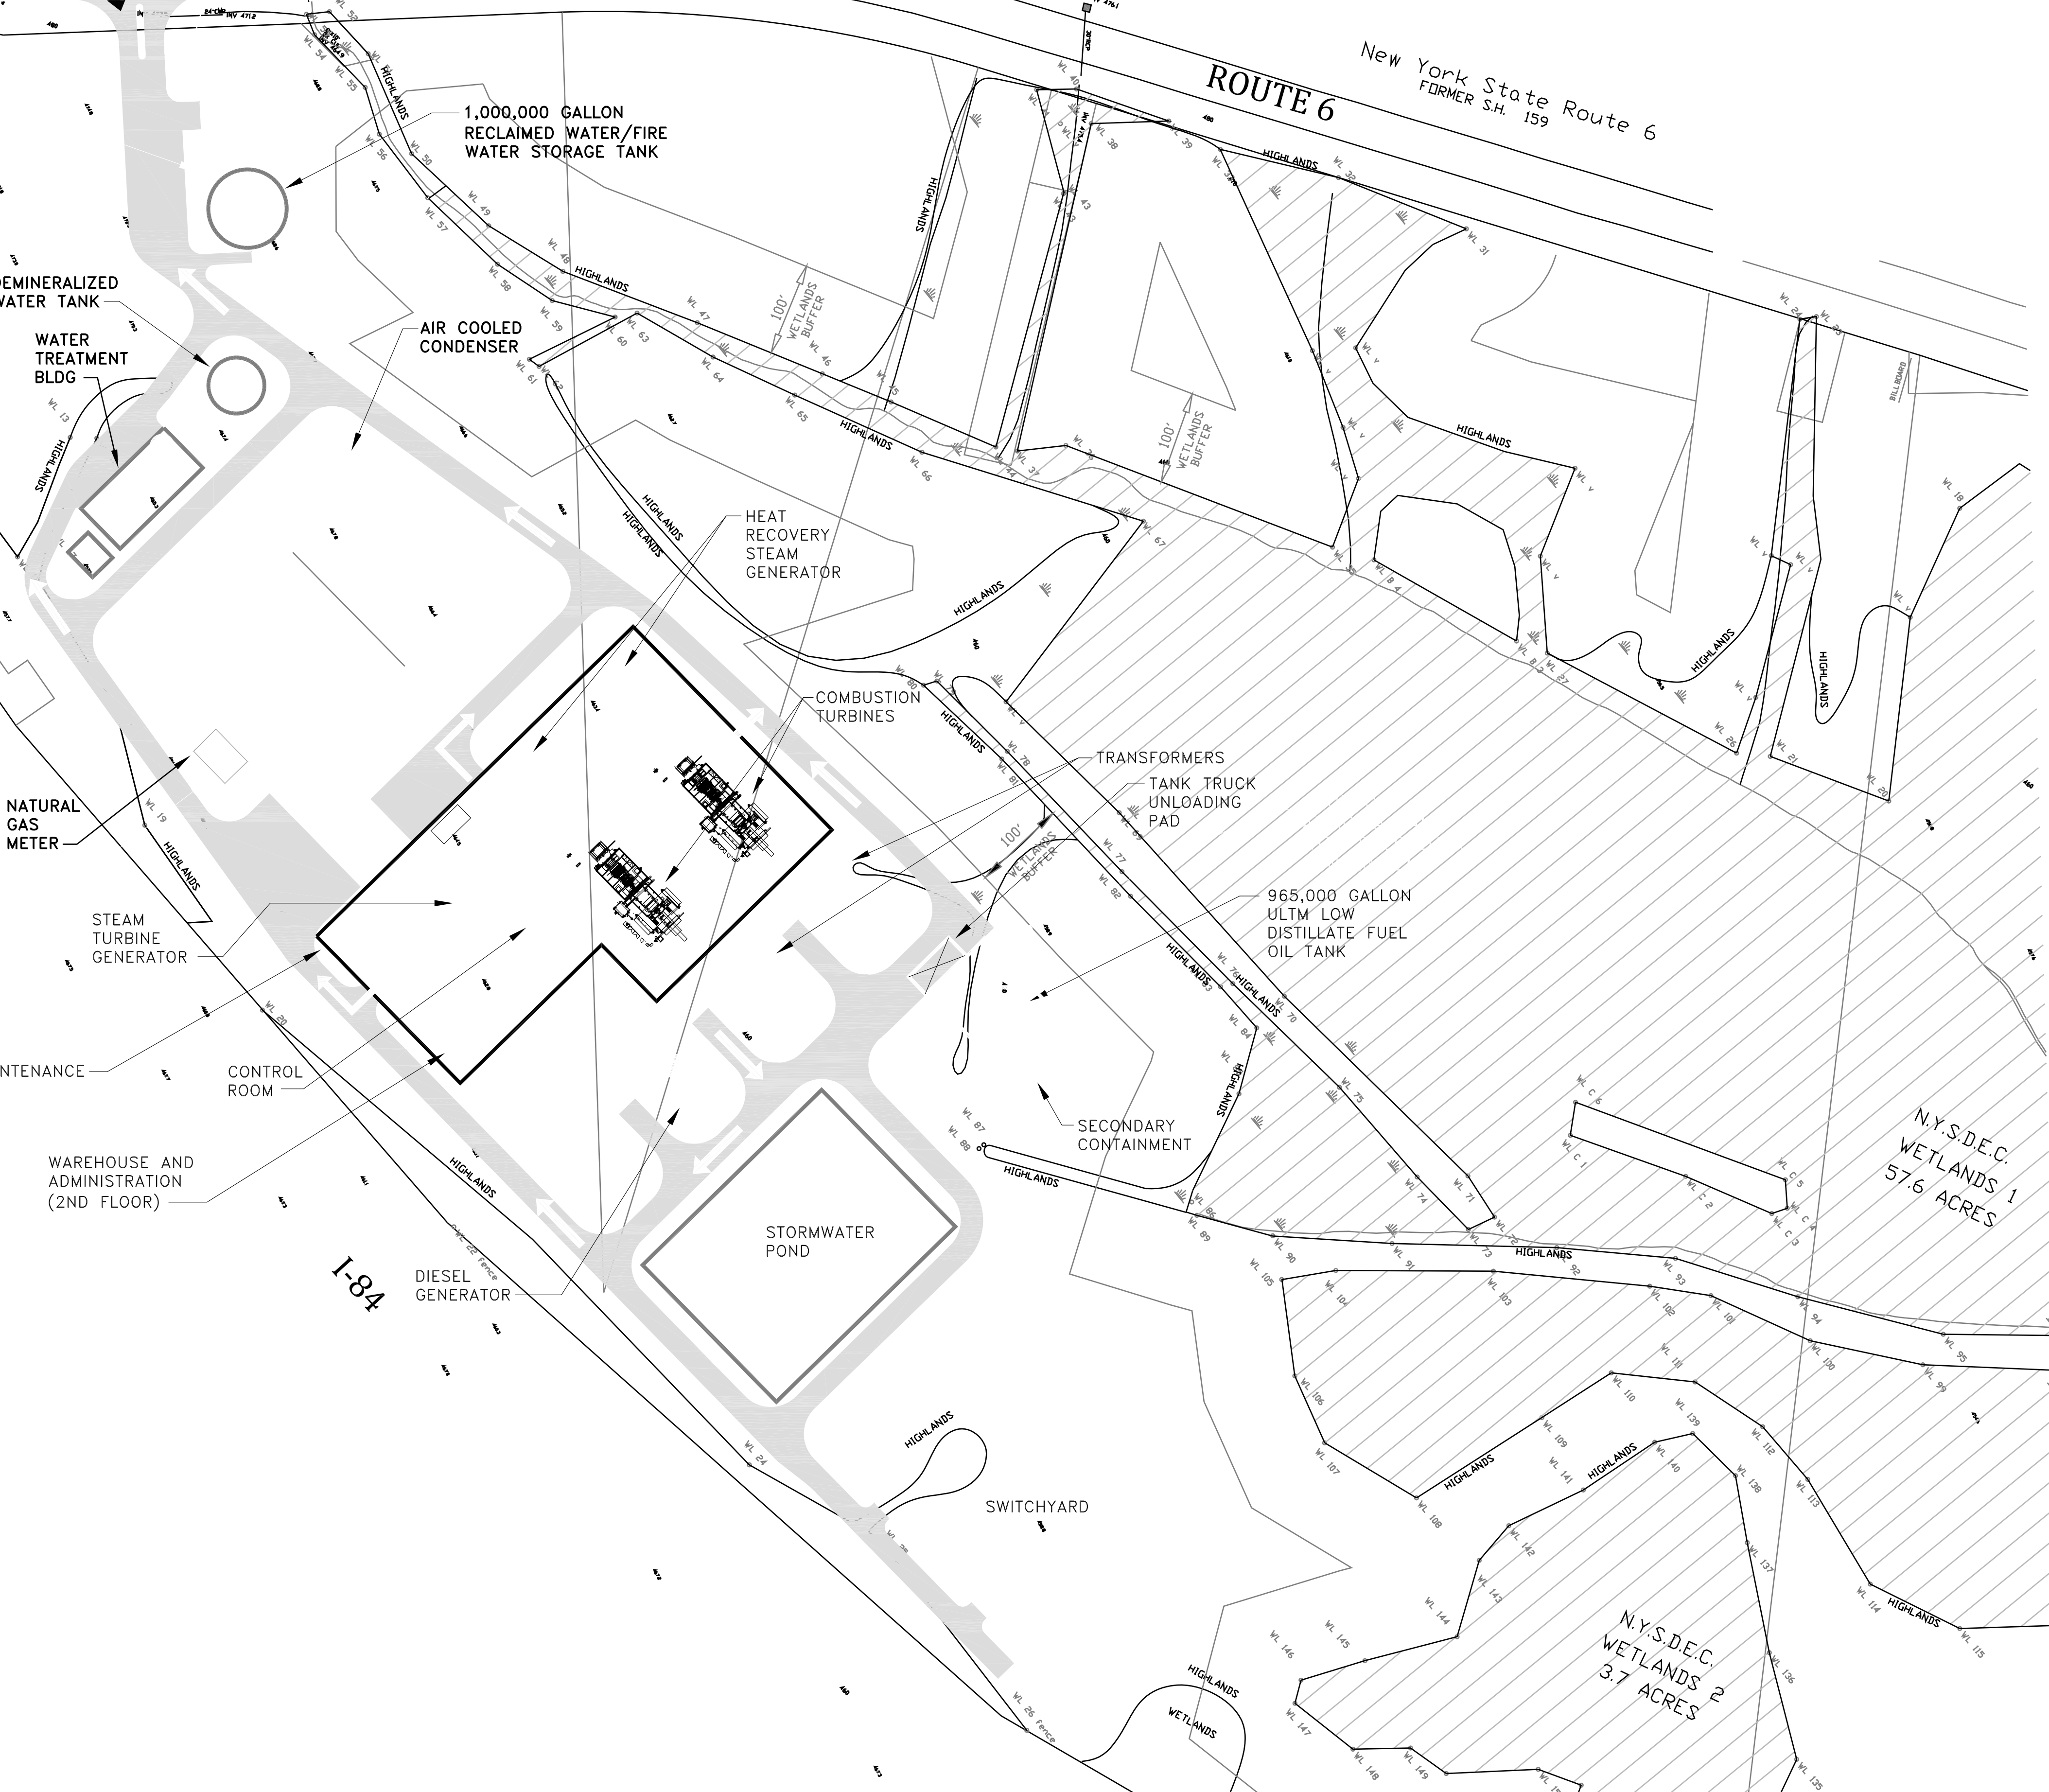

- 4 HRSG #1
 - 5 HRSG #2
 - 6 NOT USED
 - 7 HRSG STACK
 - 8 GSU TRANSFORMER #1
 - 9 GSU TRANSFORMER #2
 - 10 GSU TRANSFORMER #3
 - 11 AUXILIARY TRANSFORMER
 - 12 SWITCHYARD
 - 13 AIR COOLED CONDENSER
 - 14 PIPE RACK
 - 15 TRUCK UNLOADING AREA
 - 16 FUEL OIL TANK
 - 17 FUEL OIL PUMPS
 - 18 AUXILIARY FIN-FAN COOLER
 - 19 RECALIM/FIRE WATER STG TK (1,000,000 GAL)
 - 20 DEMINERALIZED WATER TK (400,000 GAL)
 - 21 FIRE WATER PUMP BUILDING
 - 22 VTR TRT LV SWITCHGEAR & XFMR
 - 23 AQUEOUS AMMONIA TANK & PUMPS
 - 24 COMBUSTION TURBINE BUILDING
 - 25 ELECTRICAL EQUIPMENT ROOM
 - 26 CONTROL ROOM
 - 27 ADMINISTRATION OFFICES
 - 28 WATER TREATMENT BUILDING
 - 29 MAINTENANCE
 - 30 OILY WATER SEPARATOR
 - 31 WAREHOUSE
 - 32 STEAM TURBINE GENERATOR BUILDING
 - 33 PERIMETER FENCING
 - 34 MAIN PLANT ENTRANCE/GUARD SHACK
 - 35 AUX. BOILER
 - 36 DEW POINT HEATER
 - 37 PLANT PARKING
 - 38 DIESEL GENERATOR
 - 39 DIESEL GENERATOR AUX COOLER
 - 40 NATURAL GAS METER & FILTER AREA
 - 41 NOT USED
 - 42 STORM WATER POND
 - 43 PROCESS WATER SUMP
 - 44 CONDENSATE MAKE-UP PUMPS
 - 45 NOT USED
 - 46 SWITCHYARD CONTROL BLDG.
- LOCATION OF FIRST AID KIT
 LOCATION OF SPILL KIT

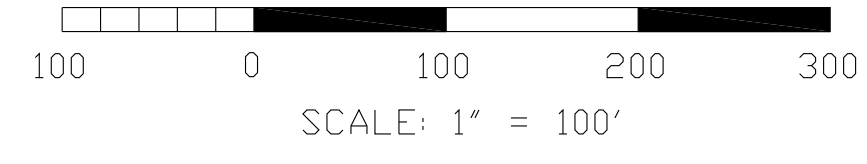

CPV VALLEY LLC	
CPV VALLEY ENERGY CENTER	
SPILL PREVENTION, CONTROL, AND COUNTERMEASURES	
CONCEPTUAL SITE PLAN	
	Wannalancit Mills 650 Suffolk Street Lowell, MA 01854 (978) 970-5600
DRAWN BY: HWB	DATE:
CHECKED BY: LL	1-05-09
FIGURE 12-2	